


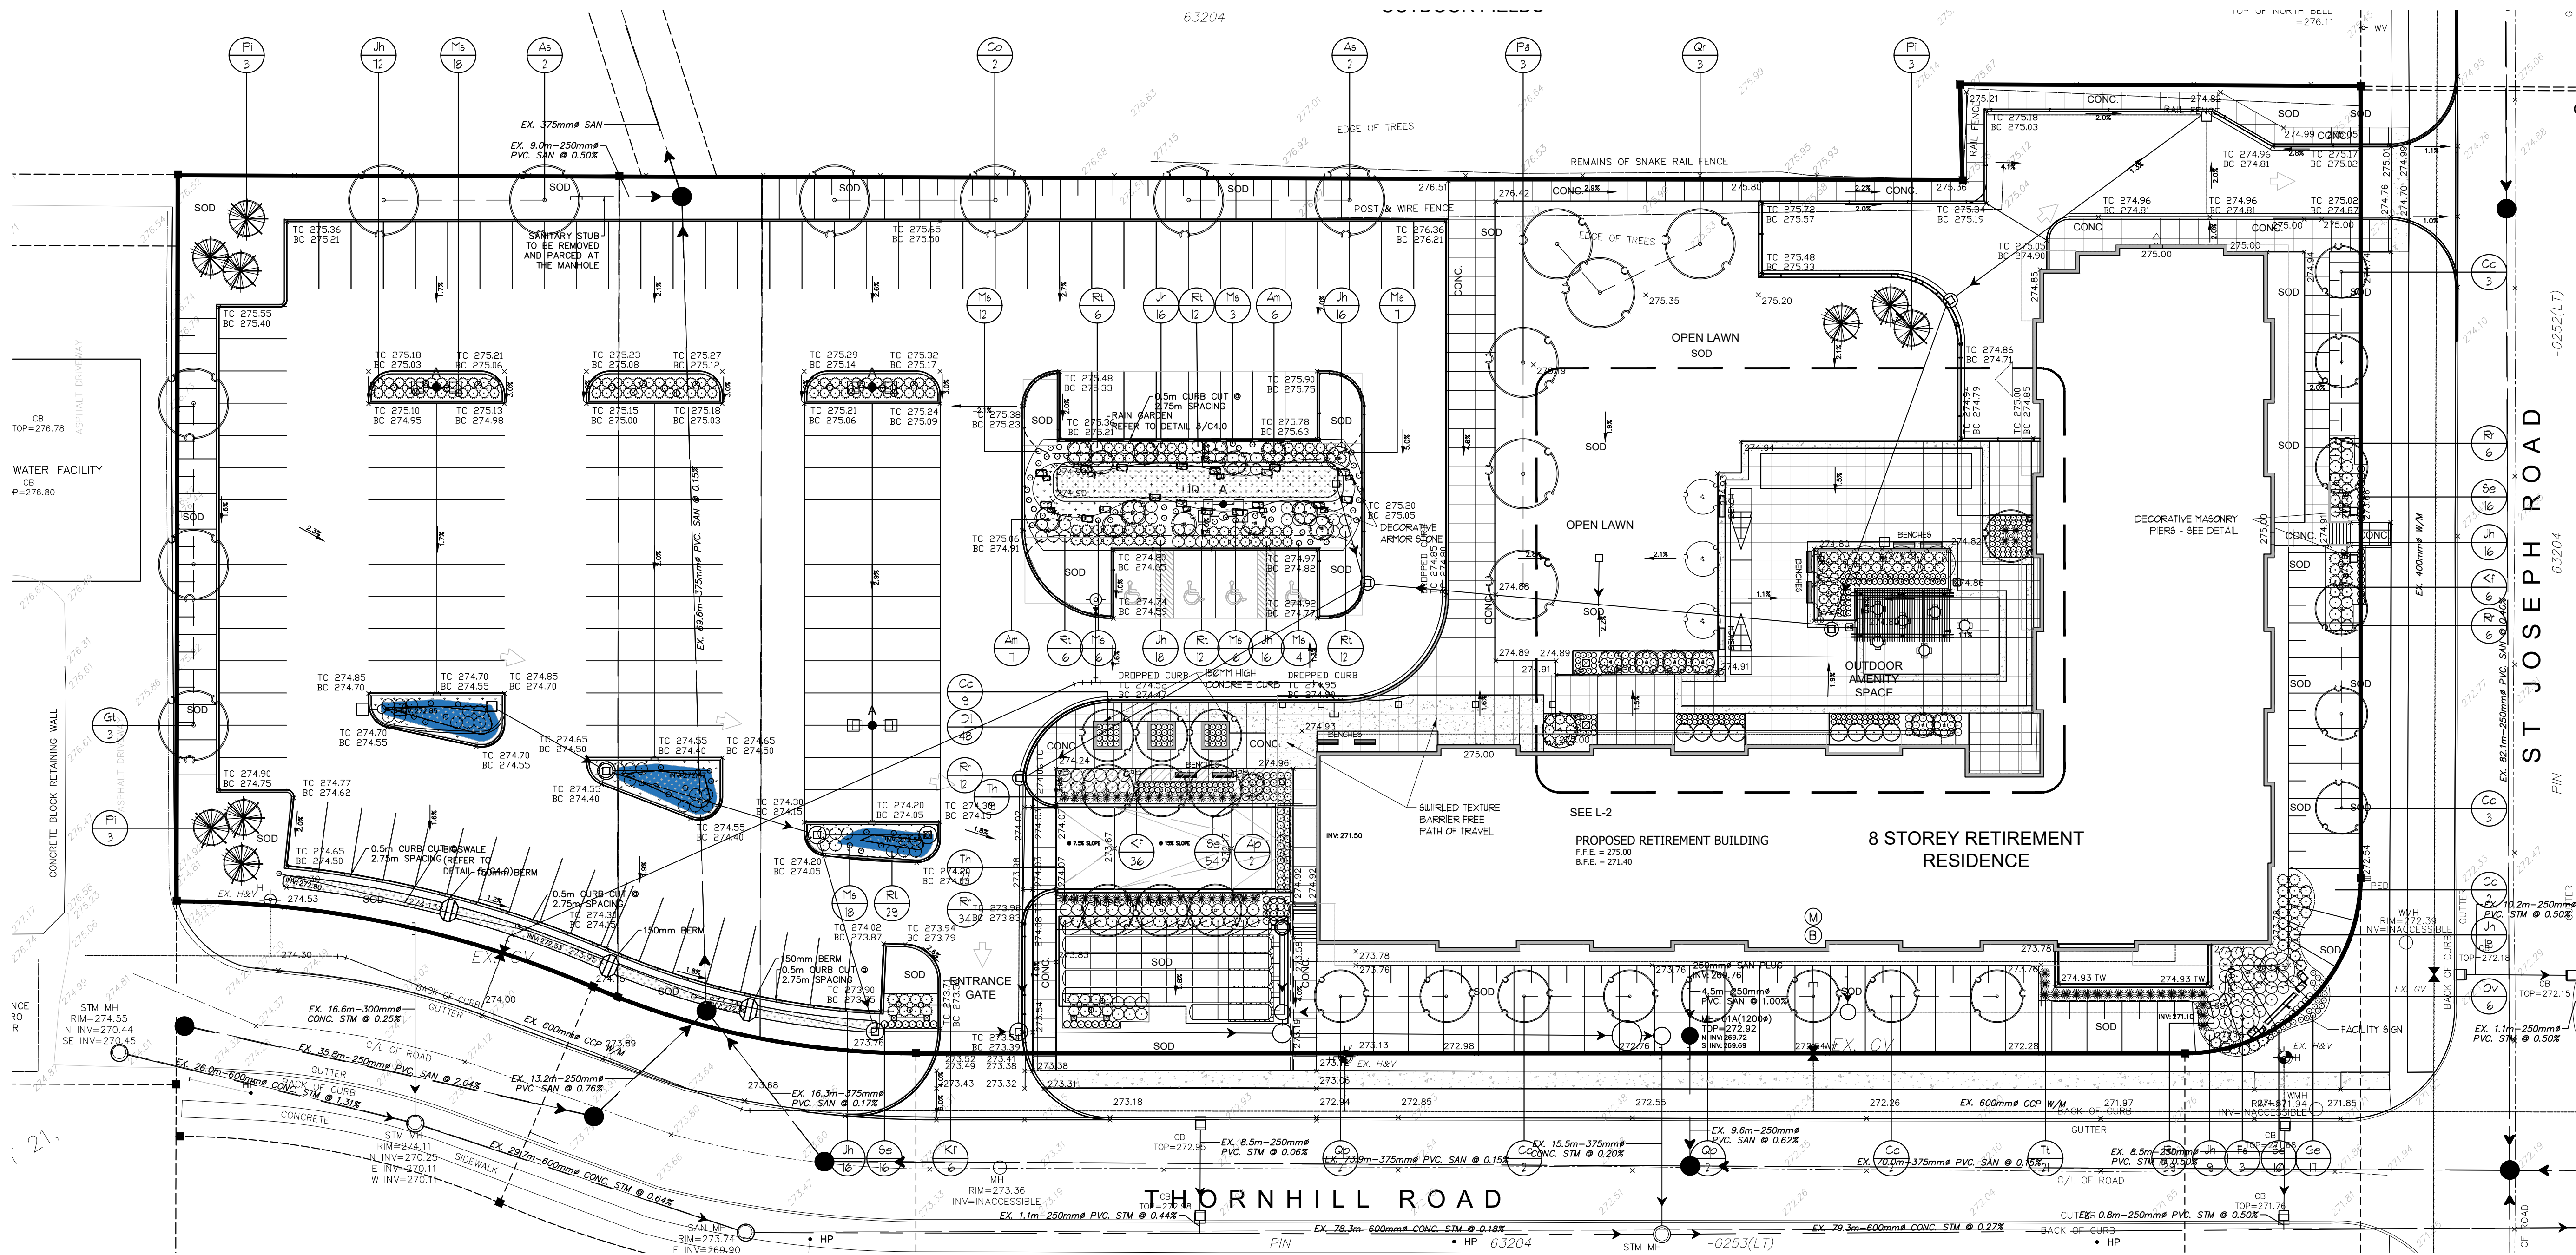


PLANT MATERIAL

KEY	COMMON NAME	BOTANICAL NAME	QTY	SIZE	COND
Am	MULTI-STEM SERVICEBERRY	Amelanchier canadensis multi-stem	13	150cm	POT
Ap	BLOODGOOD JAPANESE MAPLE	Acer palmatum 'Bloodgood'	1	150cm	POT
As	SUGAR MAPLE	Acer saccharum	4	60mcal	UB
Cc	SINGLE-STEM REDBUD	Cercis canadensis single-stem	21	45mcal	UB
Co	HACKBERRY TREE	Celtis occidentalis	2	60mcal	UB
Dl	PARDON ME DAYLILY	Hemerocallis 'Pardon Me'	48	2y'gal	POT
Fs	DUWAYOK PURPLE BEECH	Fagus sylvatica 'Purple Dasyak'	3	50mcal	UB
Ge	ROZANNE GERANIUM	Geranium 'Rozanne'	11	2y'gal	POT
Gl	SHADEMASTER LOCUST	Gleditsia triacanthos 'Shademaster'	3	60mcal	UB
Jh	PRINCE OF WALES JANIFER	Juniperus horizontalis 'Prince of Wales'	198	60cm	POT
Kf	KARL FOERSTER REED GRASS	Calamagrostis acutifolia 'Karl Foerster'	48	2y'gal	POT
Ms	HURON SUNRISE GRASS	Miscanthus sinensis 'Huron Sunrise'	14	2y'gal	POT
Ov	BLUEOAT GRASS	Helictotrichon sempervirens	6	2y'gal	POT
Pb	BLOODGOOD LONDON PLANETREE	Platanus x acerifolia 'Bloodgood'	3	60mcal	UB
Pi	WHITE SPRUCE	Picea glauca	9	200cm	UB
Qp	PIN OAK	Quercus palustris	4	60mcal	UB
Qr	RED OAK	Quercus rubra	3	60mcal	UB
R	FLOWER CARPET GROUND COVER ROSE	Rosa 'Flower Carpet'	91	60cm	POT
Rl	FRAGRANT SUMAC	Rhus aromatica 'Grou Lou'	11	60cm	POT
Se	AUTUMN JOY SEDUM	Sedum spectabile 'Autumn Joy'	96	2y'gal	POT
Th	HICKS YEW	Taxus x media 'Hickill'	41	60cm	POT
Tl	WARD'S SPREADING YEW	Taxus x media 'Wardii'	21	60cm	POT

LEGEND

	PROPOSED DECIDUOUS TREES		PROPOSED BENCH SEE DETAIL
	PROPOSED CONIFEROUS TREES		PROPOSED TRASH RECEPTACLE SEE DETAIL
	PROPOSED PLANTINGS		PROPOSED BIKE RACK SEE DETAIL
	PLANT KEYS - SEE PLANT MATERIALS LIST		PROPOSED PIER AND FENCE SEE DETAIL
	PROPOSED ARMOURSTONE SEE DETAIL		PROPOSED FENCE SEE DETAIL
	PROPOSED CONCRETE PAVING		PROPOSED FIRE HYDRANT LOCATION
	SEEDING - SEE NOTES		PROPOSED LIGHTING SEE ELECTRICAL PLAN

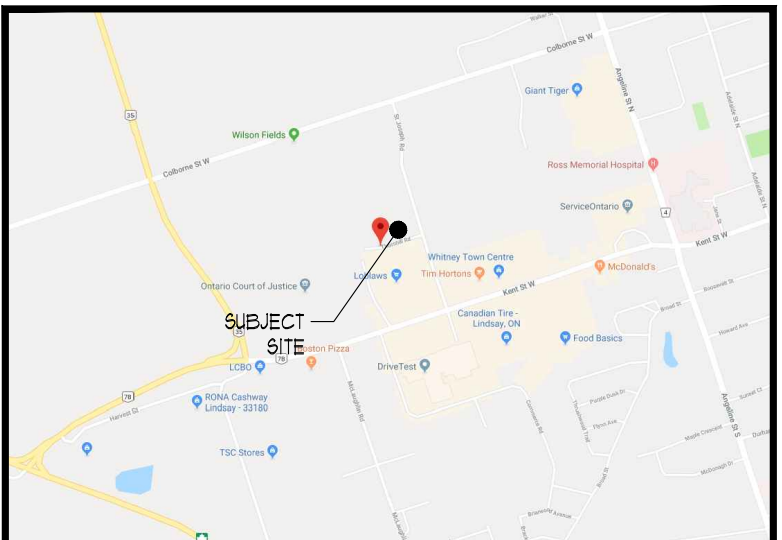

KEY MAP




ALL DRAWINGS REMAIN THE PROPERTY OF THE LANDSCAPE ARCHITECT AND SHALL NOT BE REPRODUCED OR REUSED WITHOUT THE LANDSCAPE ARCHITECTS WRITTEN PERMISSION.

THIS DRAWING SHALL NOT BE USED FOR CONSTRUCTION OR TENDER PURPOSES UNLESS SIGNED AND DATED BY RONALD H. KOUUDYS, O.A.L.A., C.S.L.A., LANDSCAPE ARCHITECT, LONDON, ONTARIO (519) 667-3322.

Ronald H. Kouudys, O.A.L.A., C.S.L.A. DATE

DATE	DESCRIPTION	No.
JUN022020	ISSUED FOR 5PA	1.
MAY222020	ISSUED FOR 5PA	6.
APR302020	ISSUED FOR 5PA	5.
MAR182020	ISSUED FOR COORDINATION	4.
OCT242019	ISSUED FOR PRESENTATION	1.
JUL312019	ISSUED FOR REZONING 4 OPA	2.
JUL242019	ISSUED FOR REVIEW	1.

PLOTTING INFORMATION:
PLOTTED DATE: JUN022020
PLOTTED SCALE: 1:1

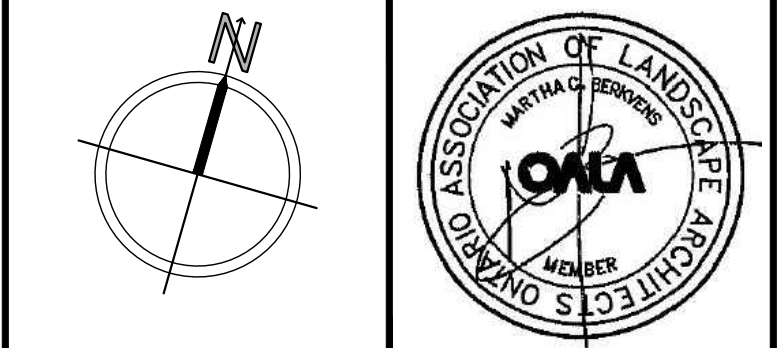

PROJECT TITLE:
FIELDGATE RETIREMENT
Thornhill Road
Lindsay, Ontario
D38-2018-091

DRAWING TITLE:
LANDSCAPE PLAN

DATE: MARCH 2019	SCALE:	DRAWING No. L-1
DRAWN: RKL4 Inc.	CHECKED BY: RAK	
PROJECT No. 19-128LI		